



A103 OVERALL FLOOR PLAN - LEVEL 03
Autodesk Docs/20256170_PSU NHB 025.m4
7/15/2028 5:04:16 PM

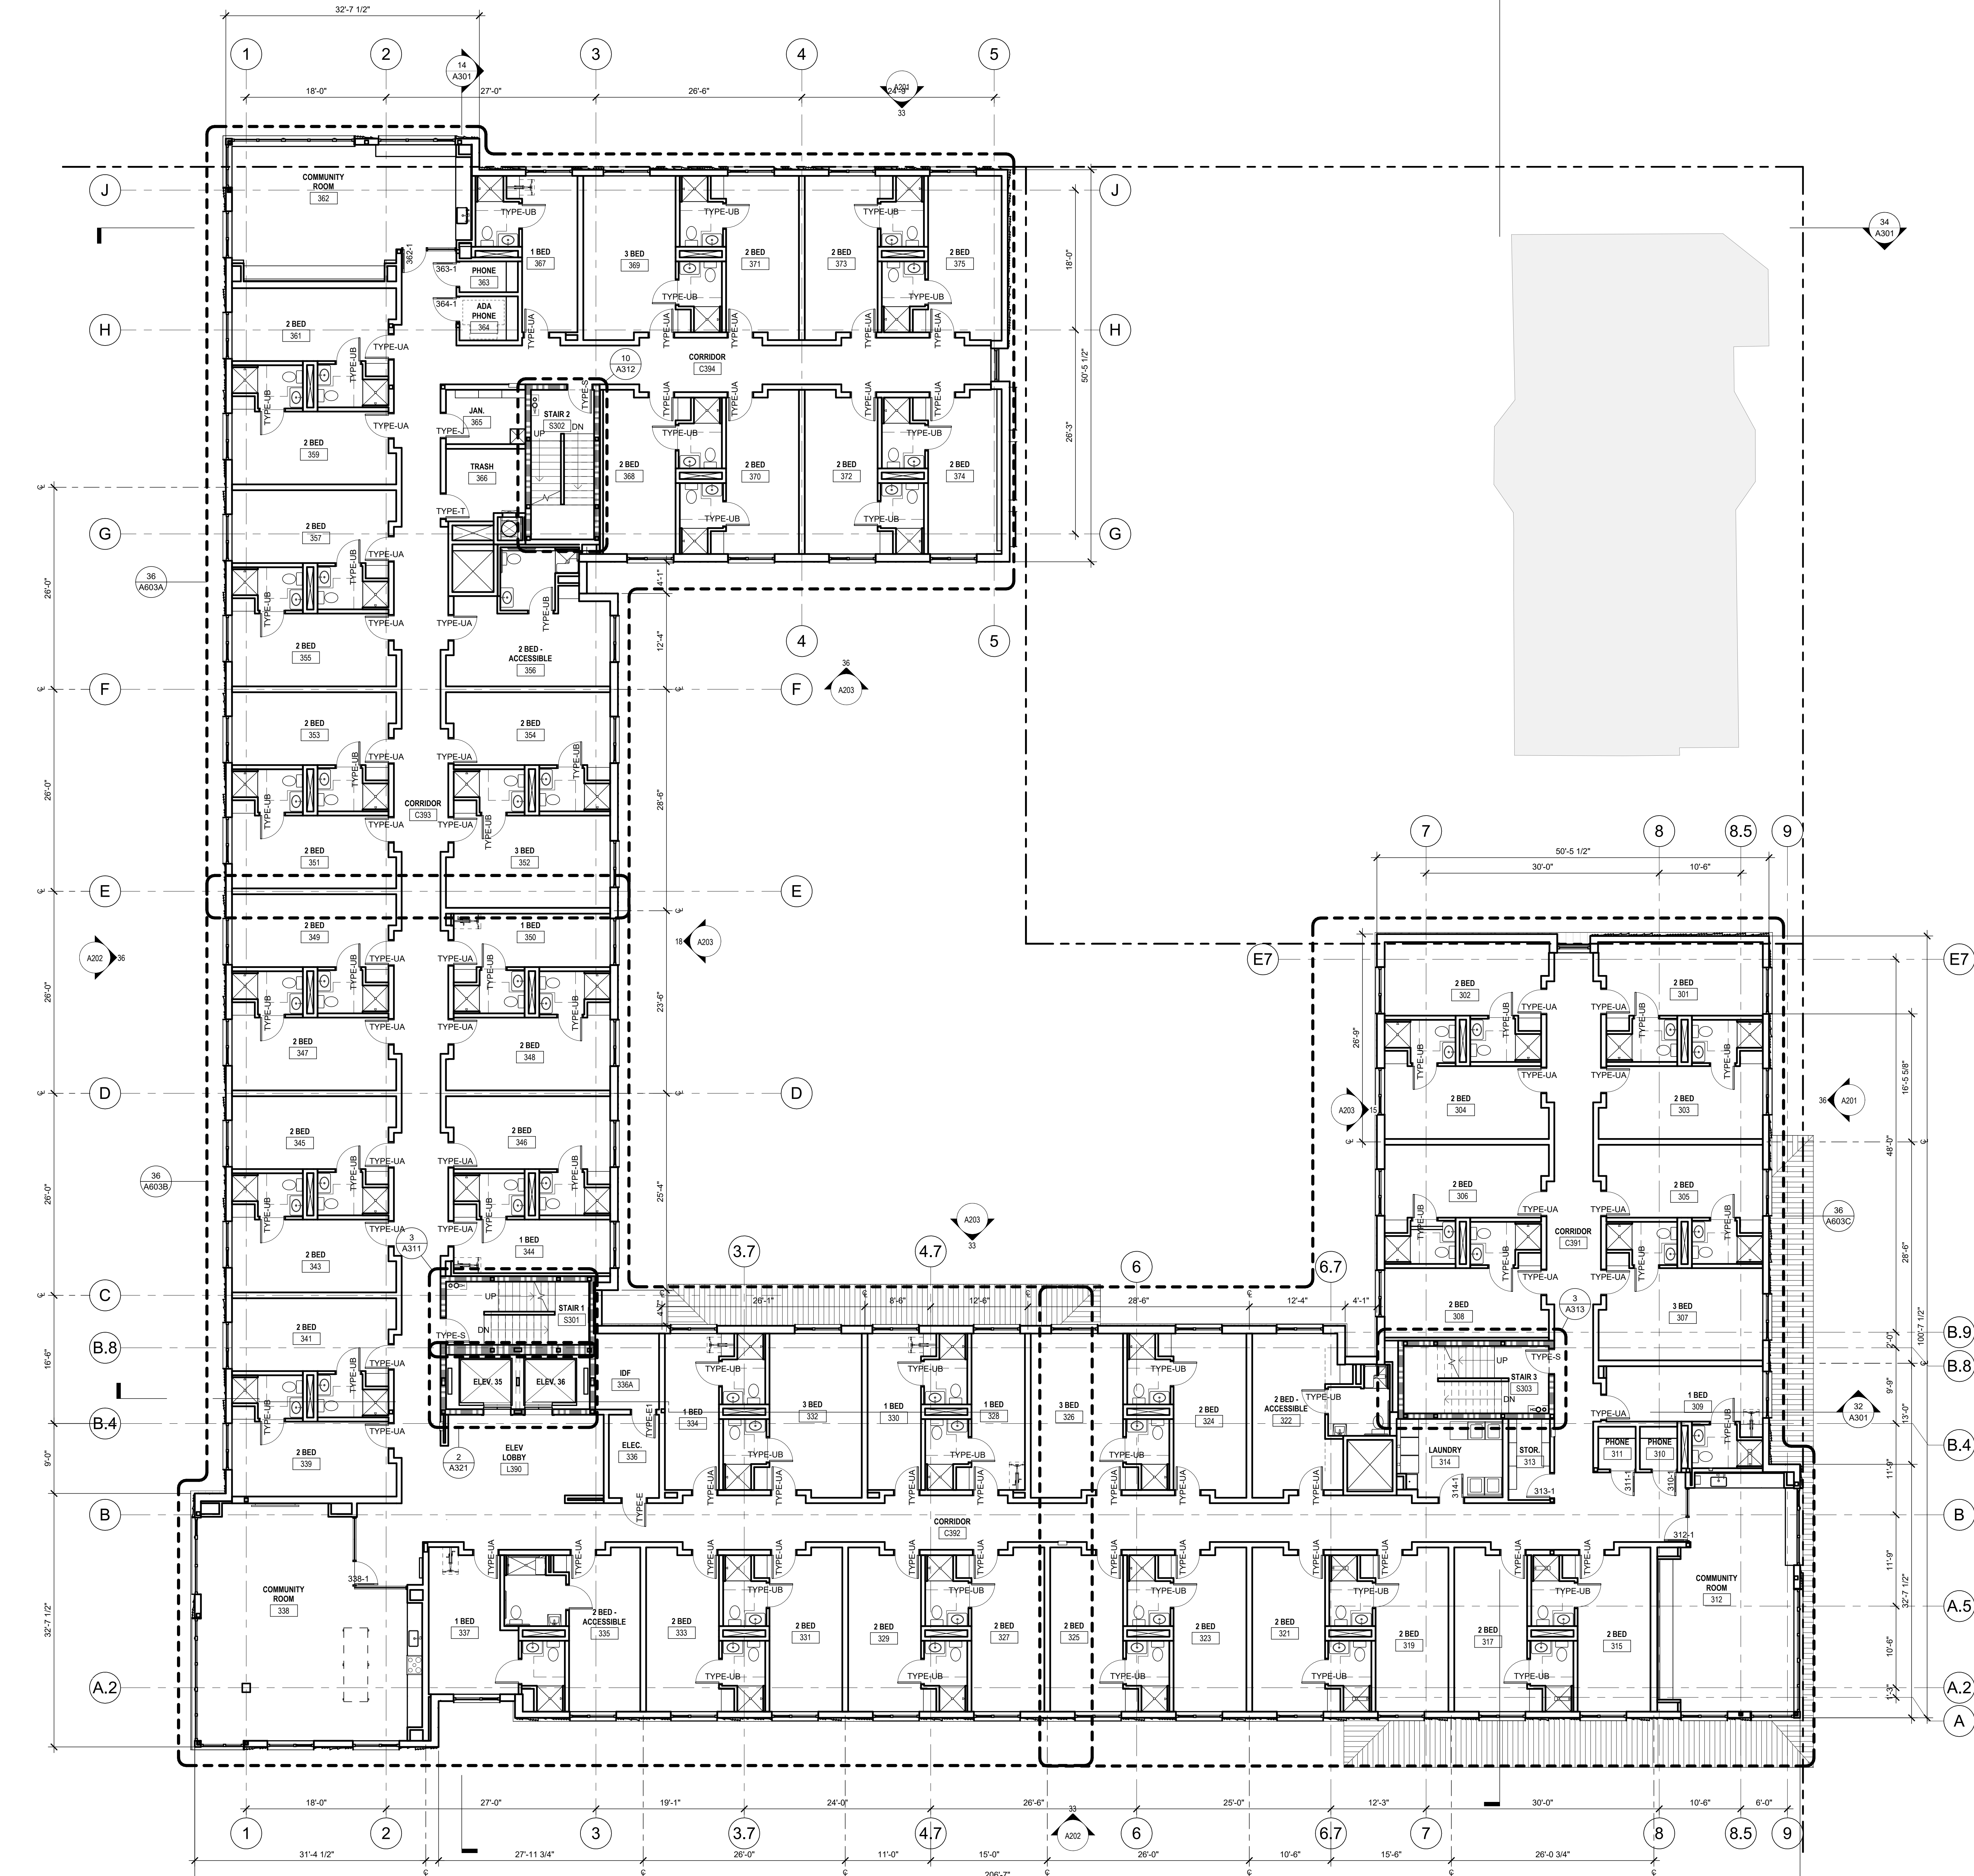

36 LEVEL 03, 05 & 6 OVERALL PLAN
1/8" = 1'-0"

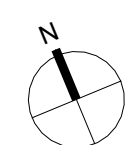

PLAN LEGEND

- ROOM NAME
- ROOM NUMBER
- REFERENCE NOTE
- NEW PARTITION
- NEW RELITE
- NEW DOOR
- DOOR NUMBER

GENERAL NOTES

- OVERLAP FAWP 4'-0" WHEN TRANSITIONING FROM EXTERIOR OR WALL TO INTERIOR OF WALL.
- ALL EXPOSED CAST-IN-PLACE CONCRETE CORNERS TO BE CHAMFERED AT 1/2".
- REFER TO SHEET A303 FOR INTERIOR FINISH LEGEND, ACCESSORY EQUIPMENT, AND PLUMBING FIXTURE SCHEDULES.

KEY ANNOTATION LEGEND

GBD

GBD Architects,
Incorporated
1120 NW Couch St.
Ste. 300
Portland, OR 97209
Tel. (503) 224-9656
gbdarchitects.com
GBD © 2026

STAMP

REGISTERED ARCHITECT
MICHELLE SCHULZ
Portland, OR
License No. 4728
STATE OF OREGON

PROJECT

Portland State University
New Housing Building
1831 SW Park Avenue &
1802 SW Montgomery Street
Portland, OR 97201

CLIENT

Portland State
University
1825 SW Broadway
Portland, OR 97201

Notice of Extended Payment
Provision: The contract will
allow the owner to make
payment within 30 days after
the date a billing or estimate is
submitted. Notice of Alternate
Billing Cycle: The contract will
allow the owner to require the
submission of billings or
estimates in billing cycles
other than 30-day cycles.
Billings or estimates for the
contract shall be submitted as
follows: Each calendar month
ending on the last day of the
applicable month.
REVISIONS

DATE

JULY 15, 2026

PROJECT NUMBER

20256170

SCALE

As indicated

SHEET TITLE

OVERALL FLOOR
PLAN - LEVEL 03

A103

PERMIT SET